




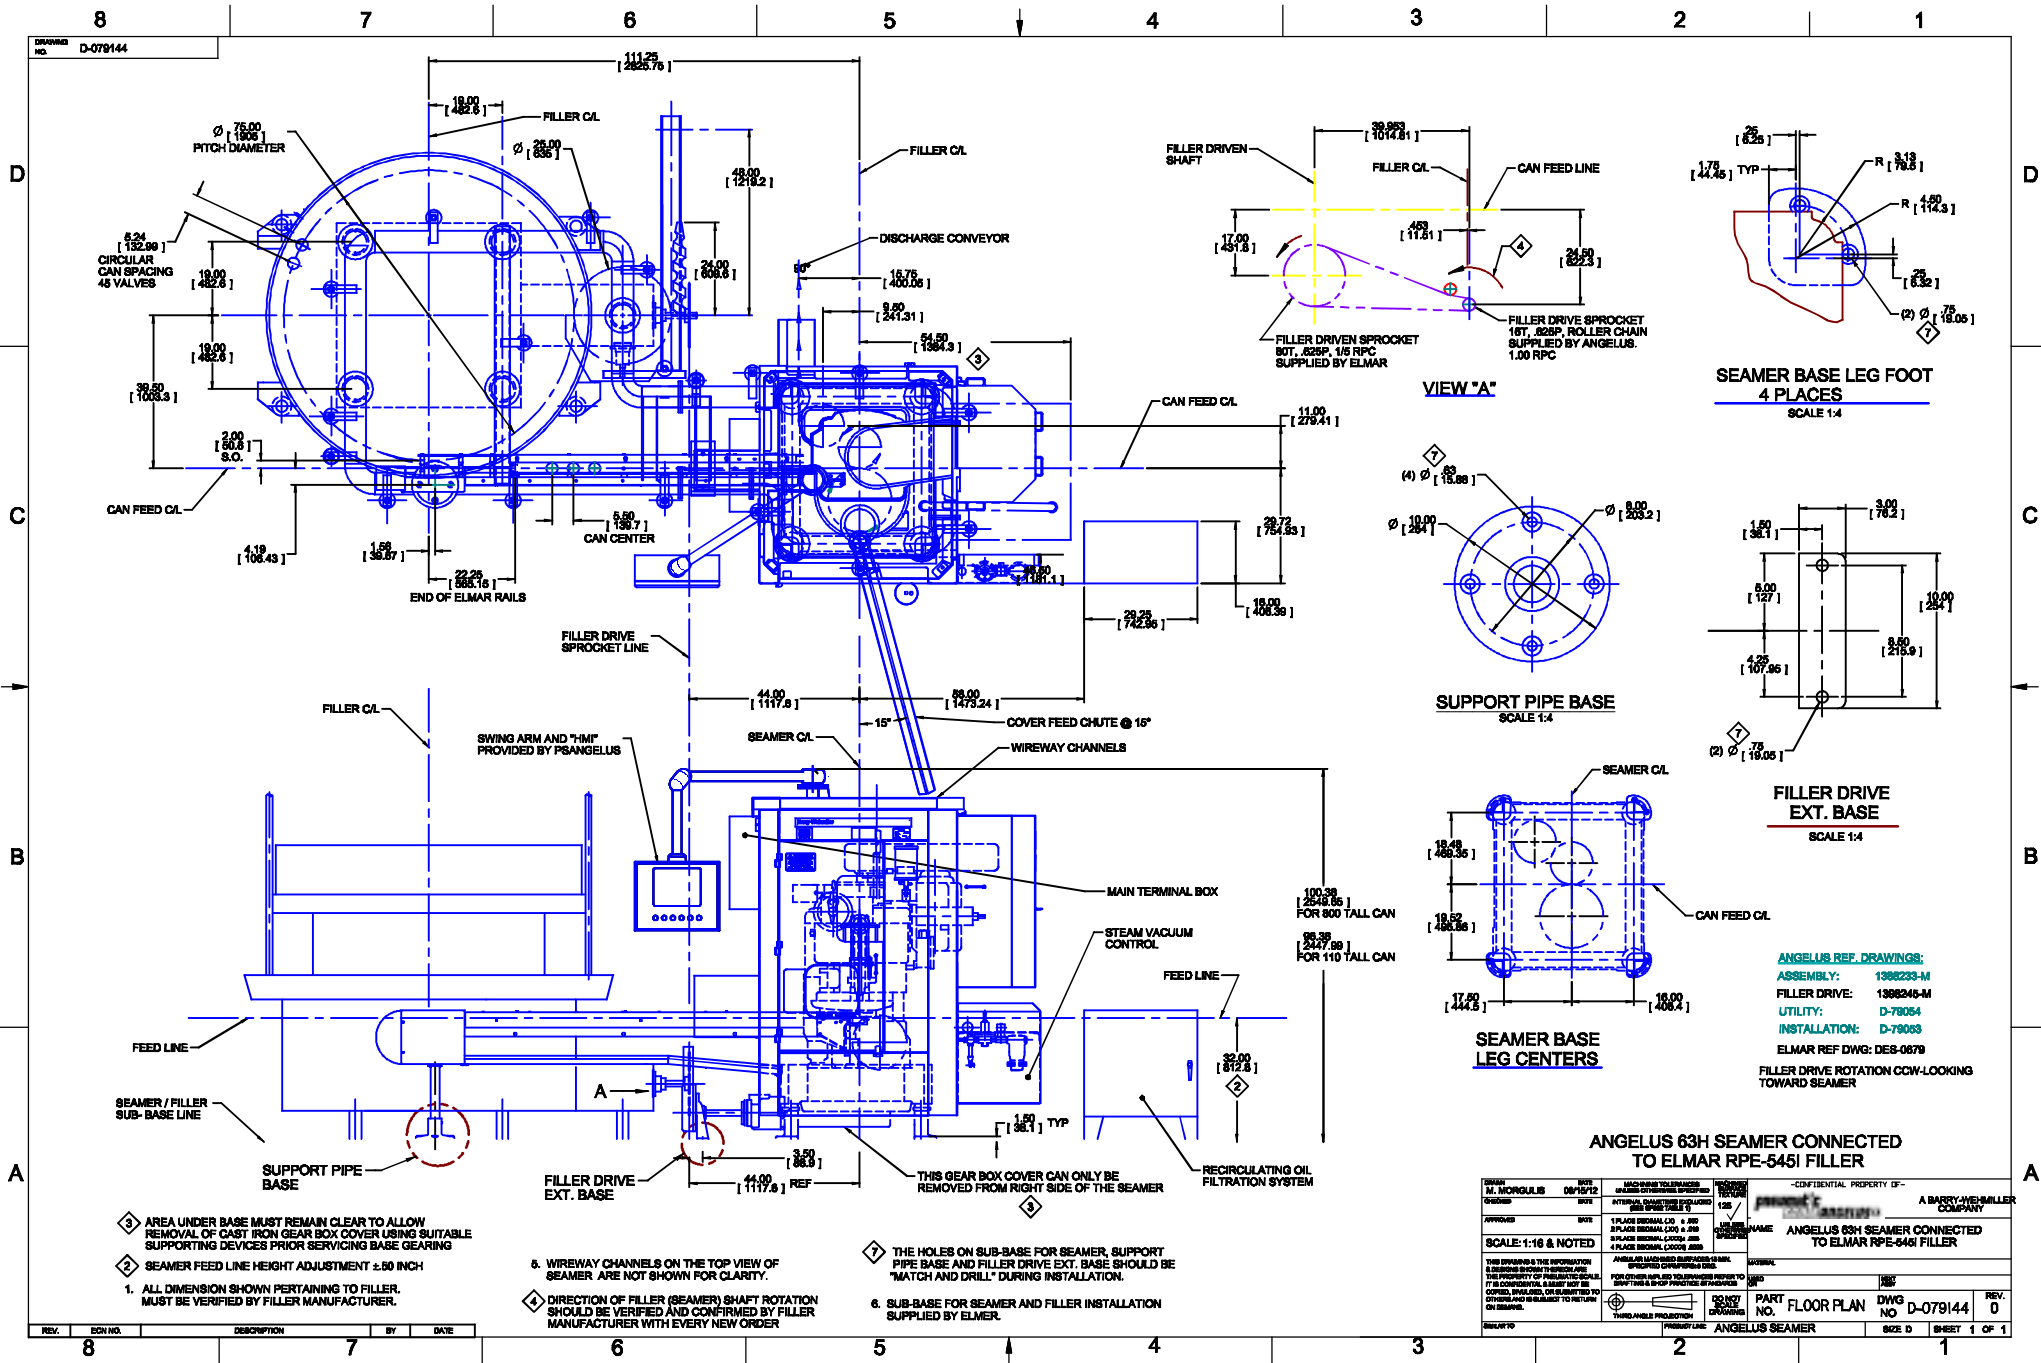


VIEW "A"

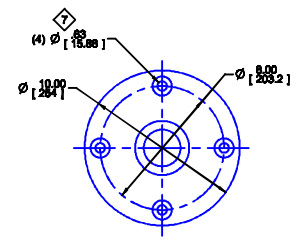


SUPPORT PIPE BASE
SCALE 1:4

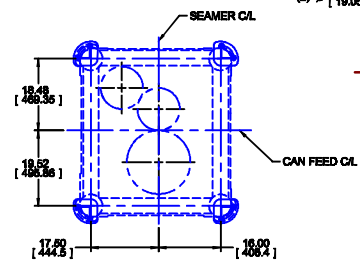

SEAMER BASE
LEG CENTERS

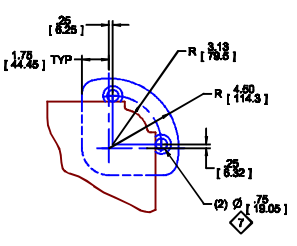

SEAMER BASE LEG FOOT
4 PLACES
SCALE 1:4

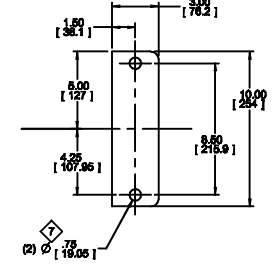

FILLER DRIVE
EXT. BASE
SCALE 1:4

ANGELUS 63H SEAMER CONNECTED
TO ELMAR RPE-545I FILLER

DRAWN BY: M. MORGAN CHECKED BY: M. MORGAN DATE: 08/10/12		PROJECT NO.: 1308223-M SCALE: 1:16 & NOTED		THIS DRAWING IS THE PROPERTY OF ANGELUS. IT IS NOT TO BE REPRODUCED OR COPIED IN ANY MANNER WITHOUT THE WRITTEN PERMISSION OF ANGELUS.	
APPROVED BY: [Signature] DATE: 08/10/12		PART NO.: FLOOR PLAN DWG NO.: D-079144		REV. 0	
ANGELUS REF. DRAWINGS: ASSEMBLY: 1308223-M FILLER DRIVE: 1308346-M UTILITY: D-78054 INSTALLATION: D-78083 ELMAR REF DWG: DES-0879 FILLER DRIVE ROTATION CCW-LOOKING TOWARD SEAMER		ANGELUS 63H SEAMER CONNECTED TO ELMAR RPE-545I FILLER		SHEET 1 OF 1	